

All dimensions to be checked on site before any work is put in hand.
 This drawing to be read in conjunction with Engineer's drawings when applicable. Any discrepancies and ambiguities on this drawing to be reported to Architect. Dimensions not to be scaled
 Copyright reserved

Revision History:

RevID	Change ID	Revision	Issue Date

Ceiling & Lighting Notes


- All existing ceiling panels to be cleaned
- All grid lights to be re-used

Ceiling Legend

- Existing grid ceiling
- New grid to be installed, re-use existing ceiling panels as far as possible
- New Bulkhead

Lighting Legend

- New proposed position for grid light. Re-use removed grid lights
- Existing grid lights
- Remove existing grid lights and re-use in new proposed locations
- New downlighters
- New pendant lights
- New LED strips in Bulkheads

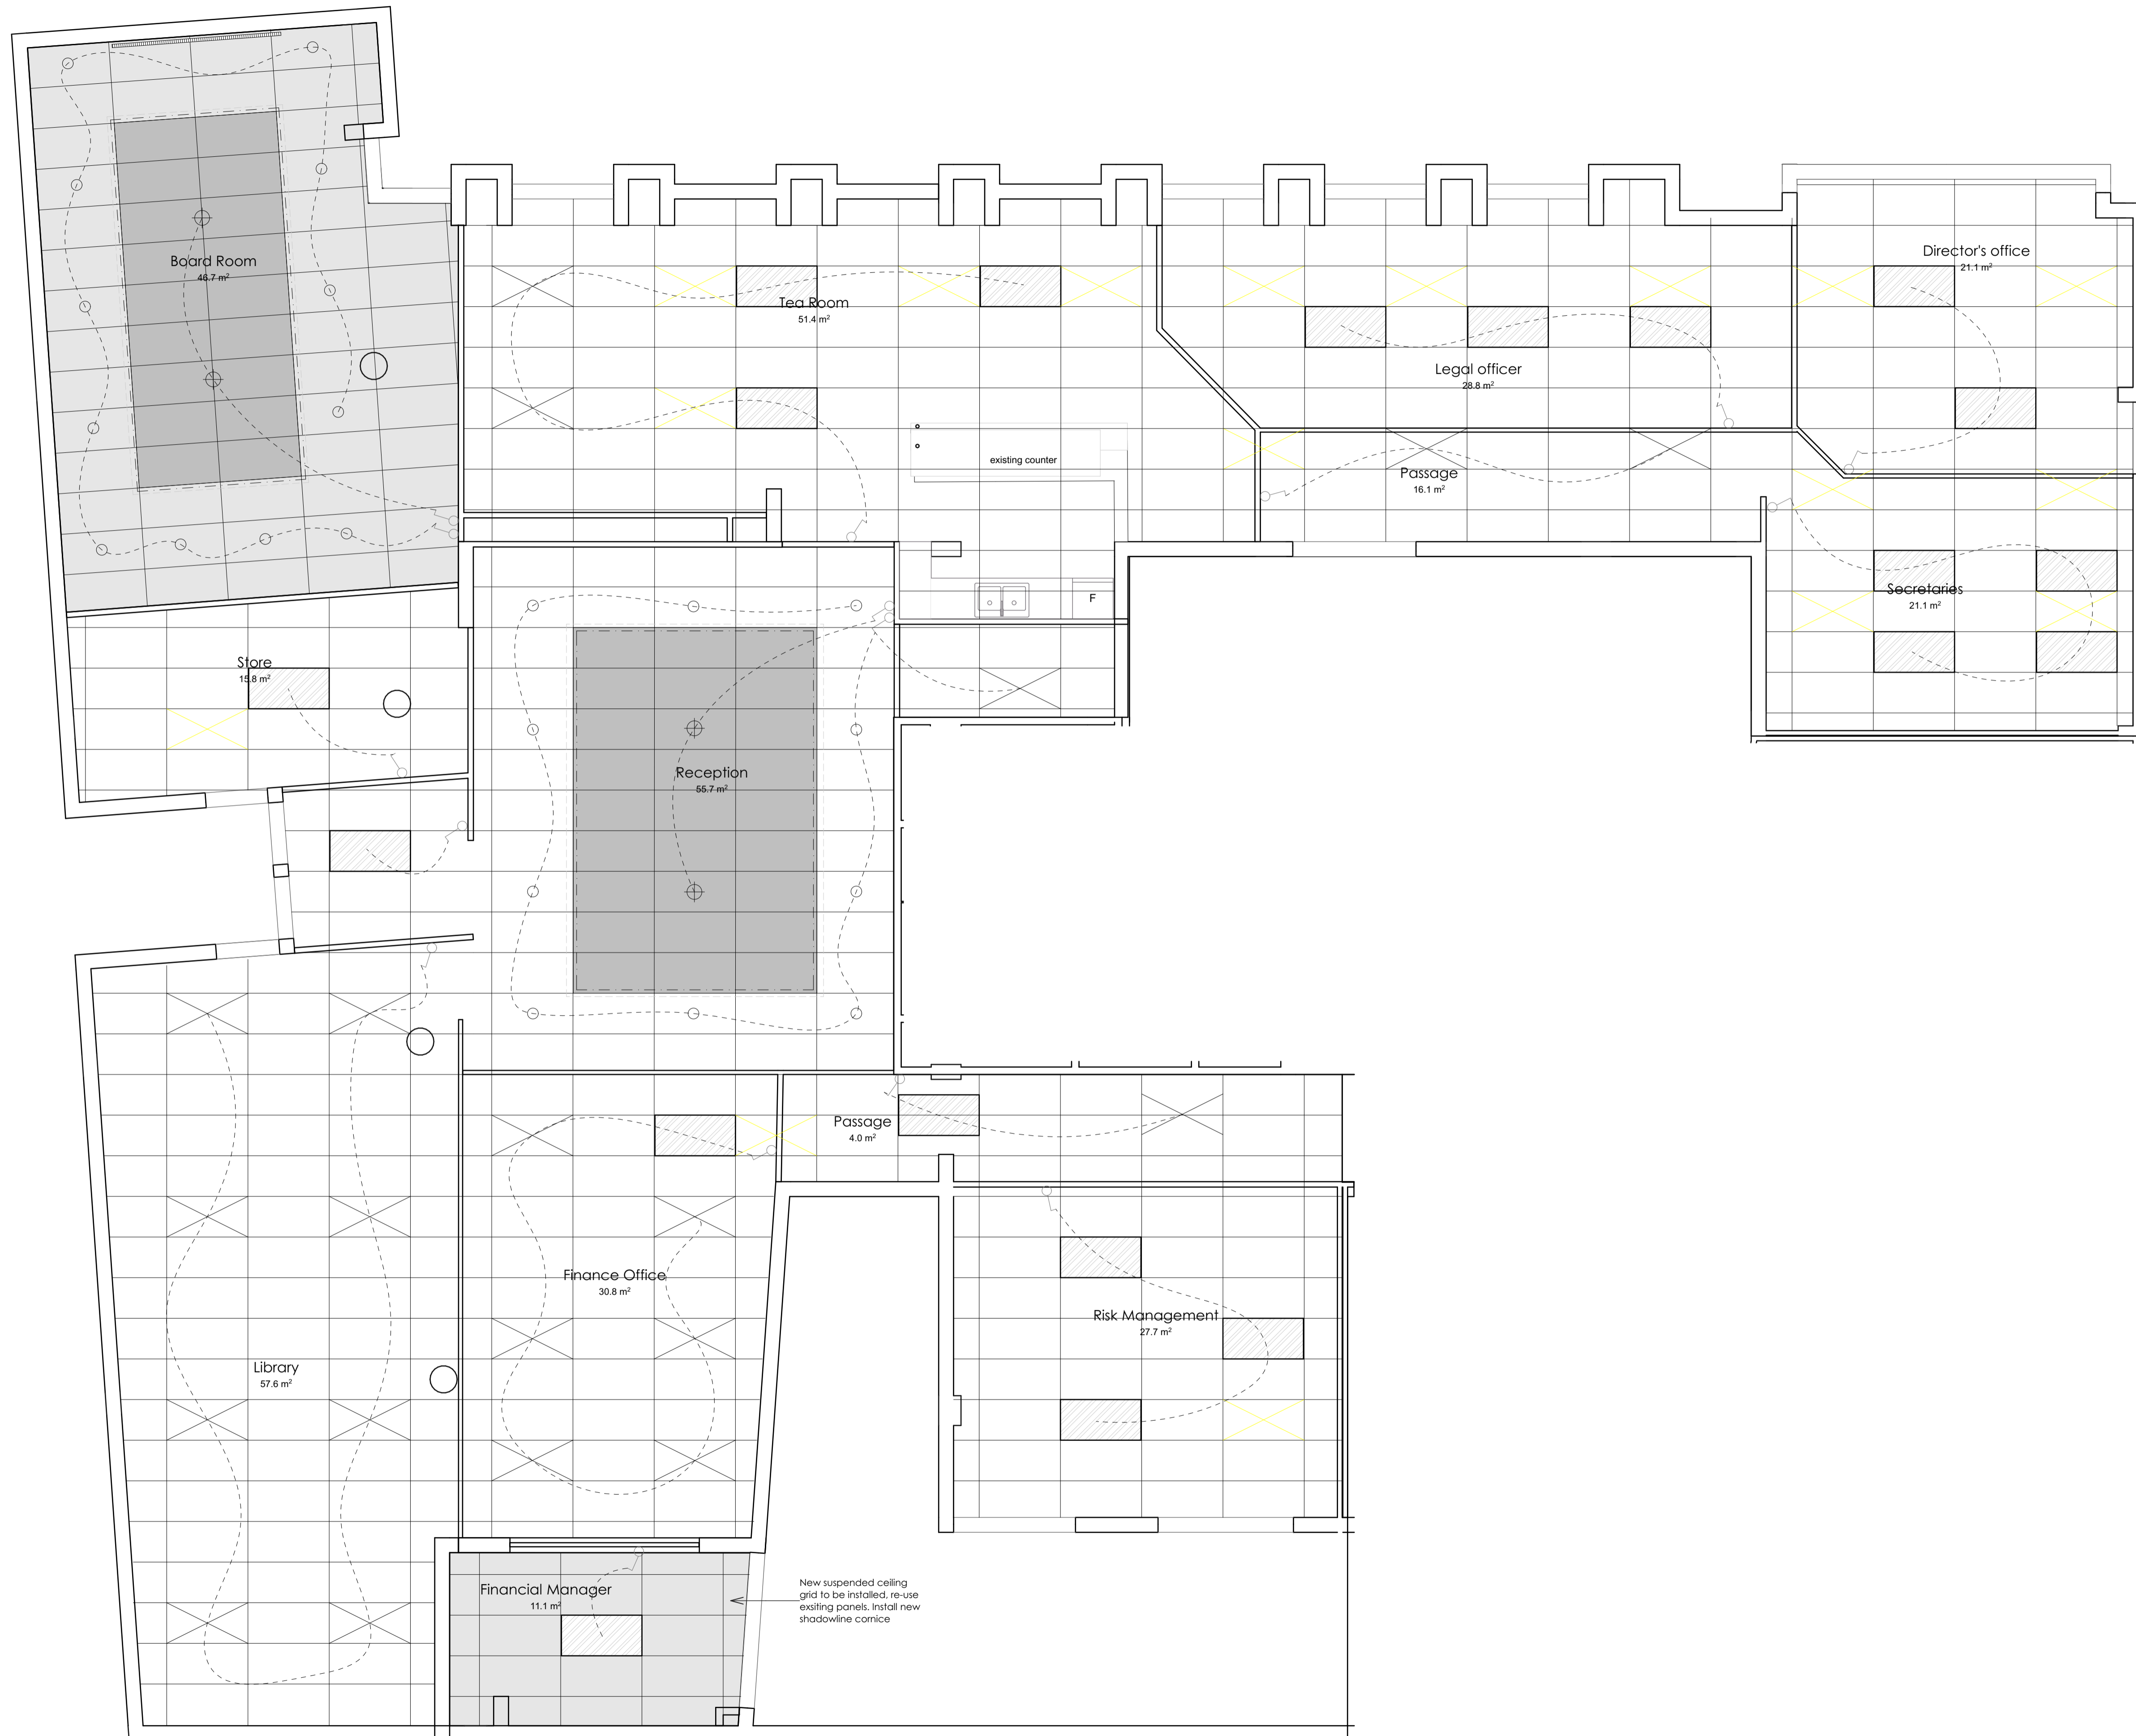

Ceiling & Lighting Plan
 Scale 1:50

Unit 31, Hyper motor city, Maxwell street
 P.O. Box 31059, Windhoek
 Tel: +264 61 333810 - 12th 085 655 5367
 www.mbarbani.com • mbarbani@barbani.com



Client:
The Law Society of Namibia
 #Client Postal Box

Project:
 Law Society Renovation
 First Floor, Namlex Chambers 333
 Independence Avenue Windhoek

Status:
 Tender Documentation

Drawing Title:
 Ceiling & Lighting Plan

Scale:	Project No:	Drawing No:	Revision:
Date: 28 March 2019	331	3/104	
Drawn: AR			

A Goal without a plan is just a wish